


EXCEPT WITH RESPECT TO THE OBLIGATIONS OF LANDLORD WHICH ARE EXPRESSLY PROVIDED IN THE LEASE, LANDLORD HAS MADE NO AGREEMENT, REPRESENTATION OR WARRANTY WITH RESPECT TO THE STATUS OR EXISTENCE OF ANY LEASE, OCCUPANCY OR USAGE OF ANY SPACE, OR THE EXISTENCE, DESIGN OR LOCATION OF ANY BUILDINGS, IMPROVEMENTS, PARKING AREAS, CURB CUTS, DRIVES OR OTHER COMMON AREAS WITH RESPECT TO THE SHOPPING CENTER OR ANY OUTPARCELS OR OTHER PROPERTY. LANDLORD BELIEVES THAT THE INFORMATION CONTAINED WITHIN THIS DRAWING IS PRESENTLY CORRECT, BUT LANDLORD MAKES NO WARRANTY, REPRESENTATION OR GUARANTEE AS TO ITS ACCURACY OR WHETHER IT WILL REMAIN AS CONFIGURED, AND LANDLORD RECOMMENDS THAT ALL INFORMATION BE FIELD VERIFIED PRIOR TO DESIGN AND CONSTRUCTION.

**SUITE 1**  
ELECTRICAL SERVICE: 175 AMP 120/208 VOLT  
3 PHASE 4 WIRE  
HVAC: 3 & 4 TONS  
ADA RESTROOM

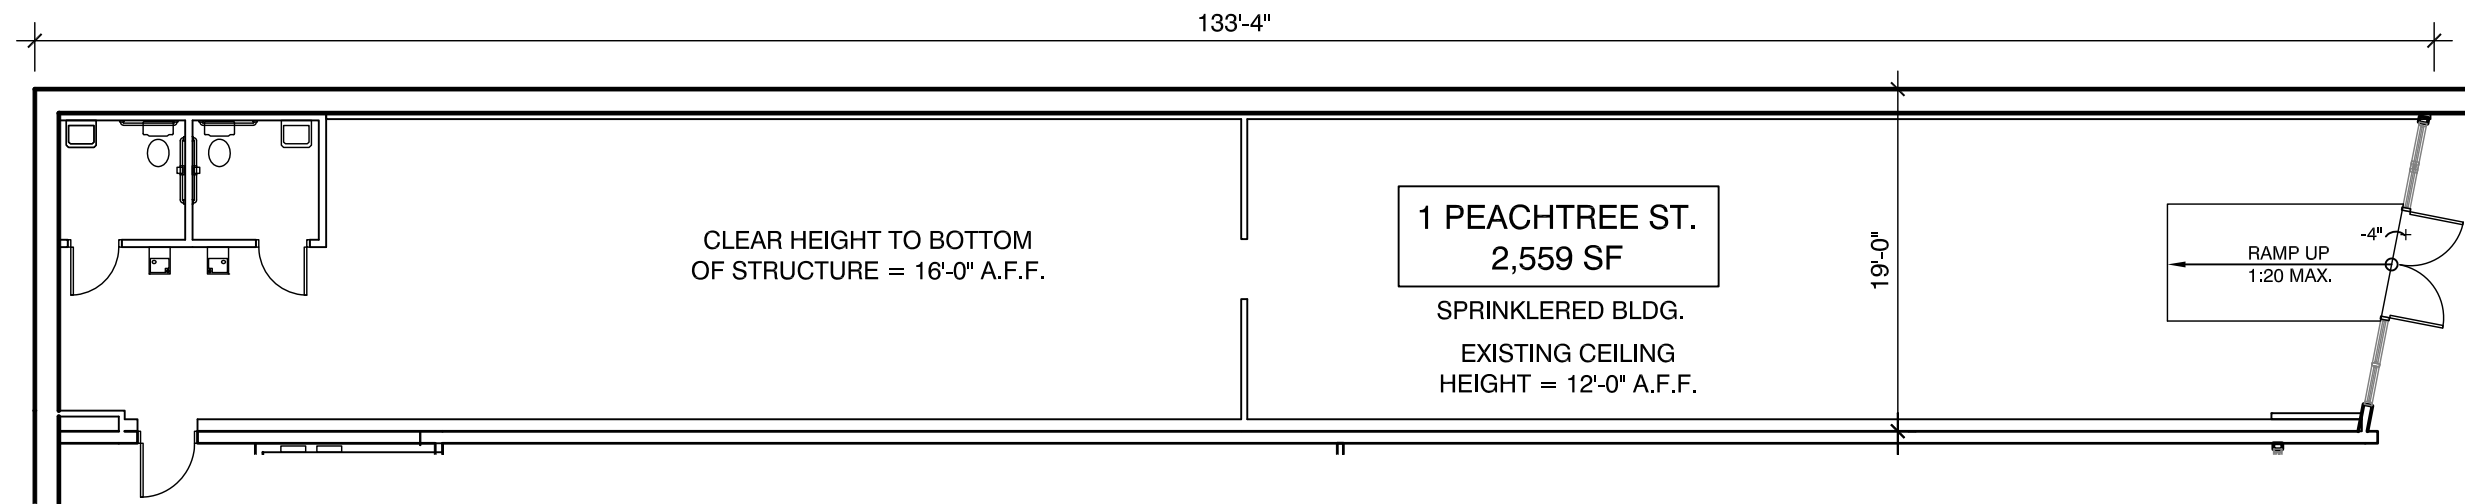

# FIVE POINTS PLAZA: SUITE 1 - FLOOR PLAN

1 PEACHTREE STREET  
ATLANTA, GA. 30303

SCALE: 3/32" = 1'-0"

DRAWN BY: CO

DATE: 02/03/15



1100 SPRING STREET NW SUITE 550  
ATLANTA, GEORGIA 30309-2848  
TEL (404) 876-5511 FAX (404) 875-2629

USER: conell - Feb 03, 2015 - 3:02pm  
S:\CONSTRUCTION\AutoCAD\As\_Built Drawings\Retail\Five Points Plaza\LOD\Five Points 1-31 LOD.dwg